


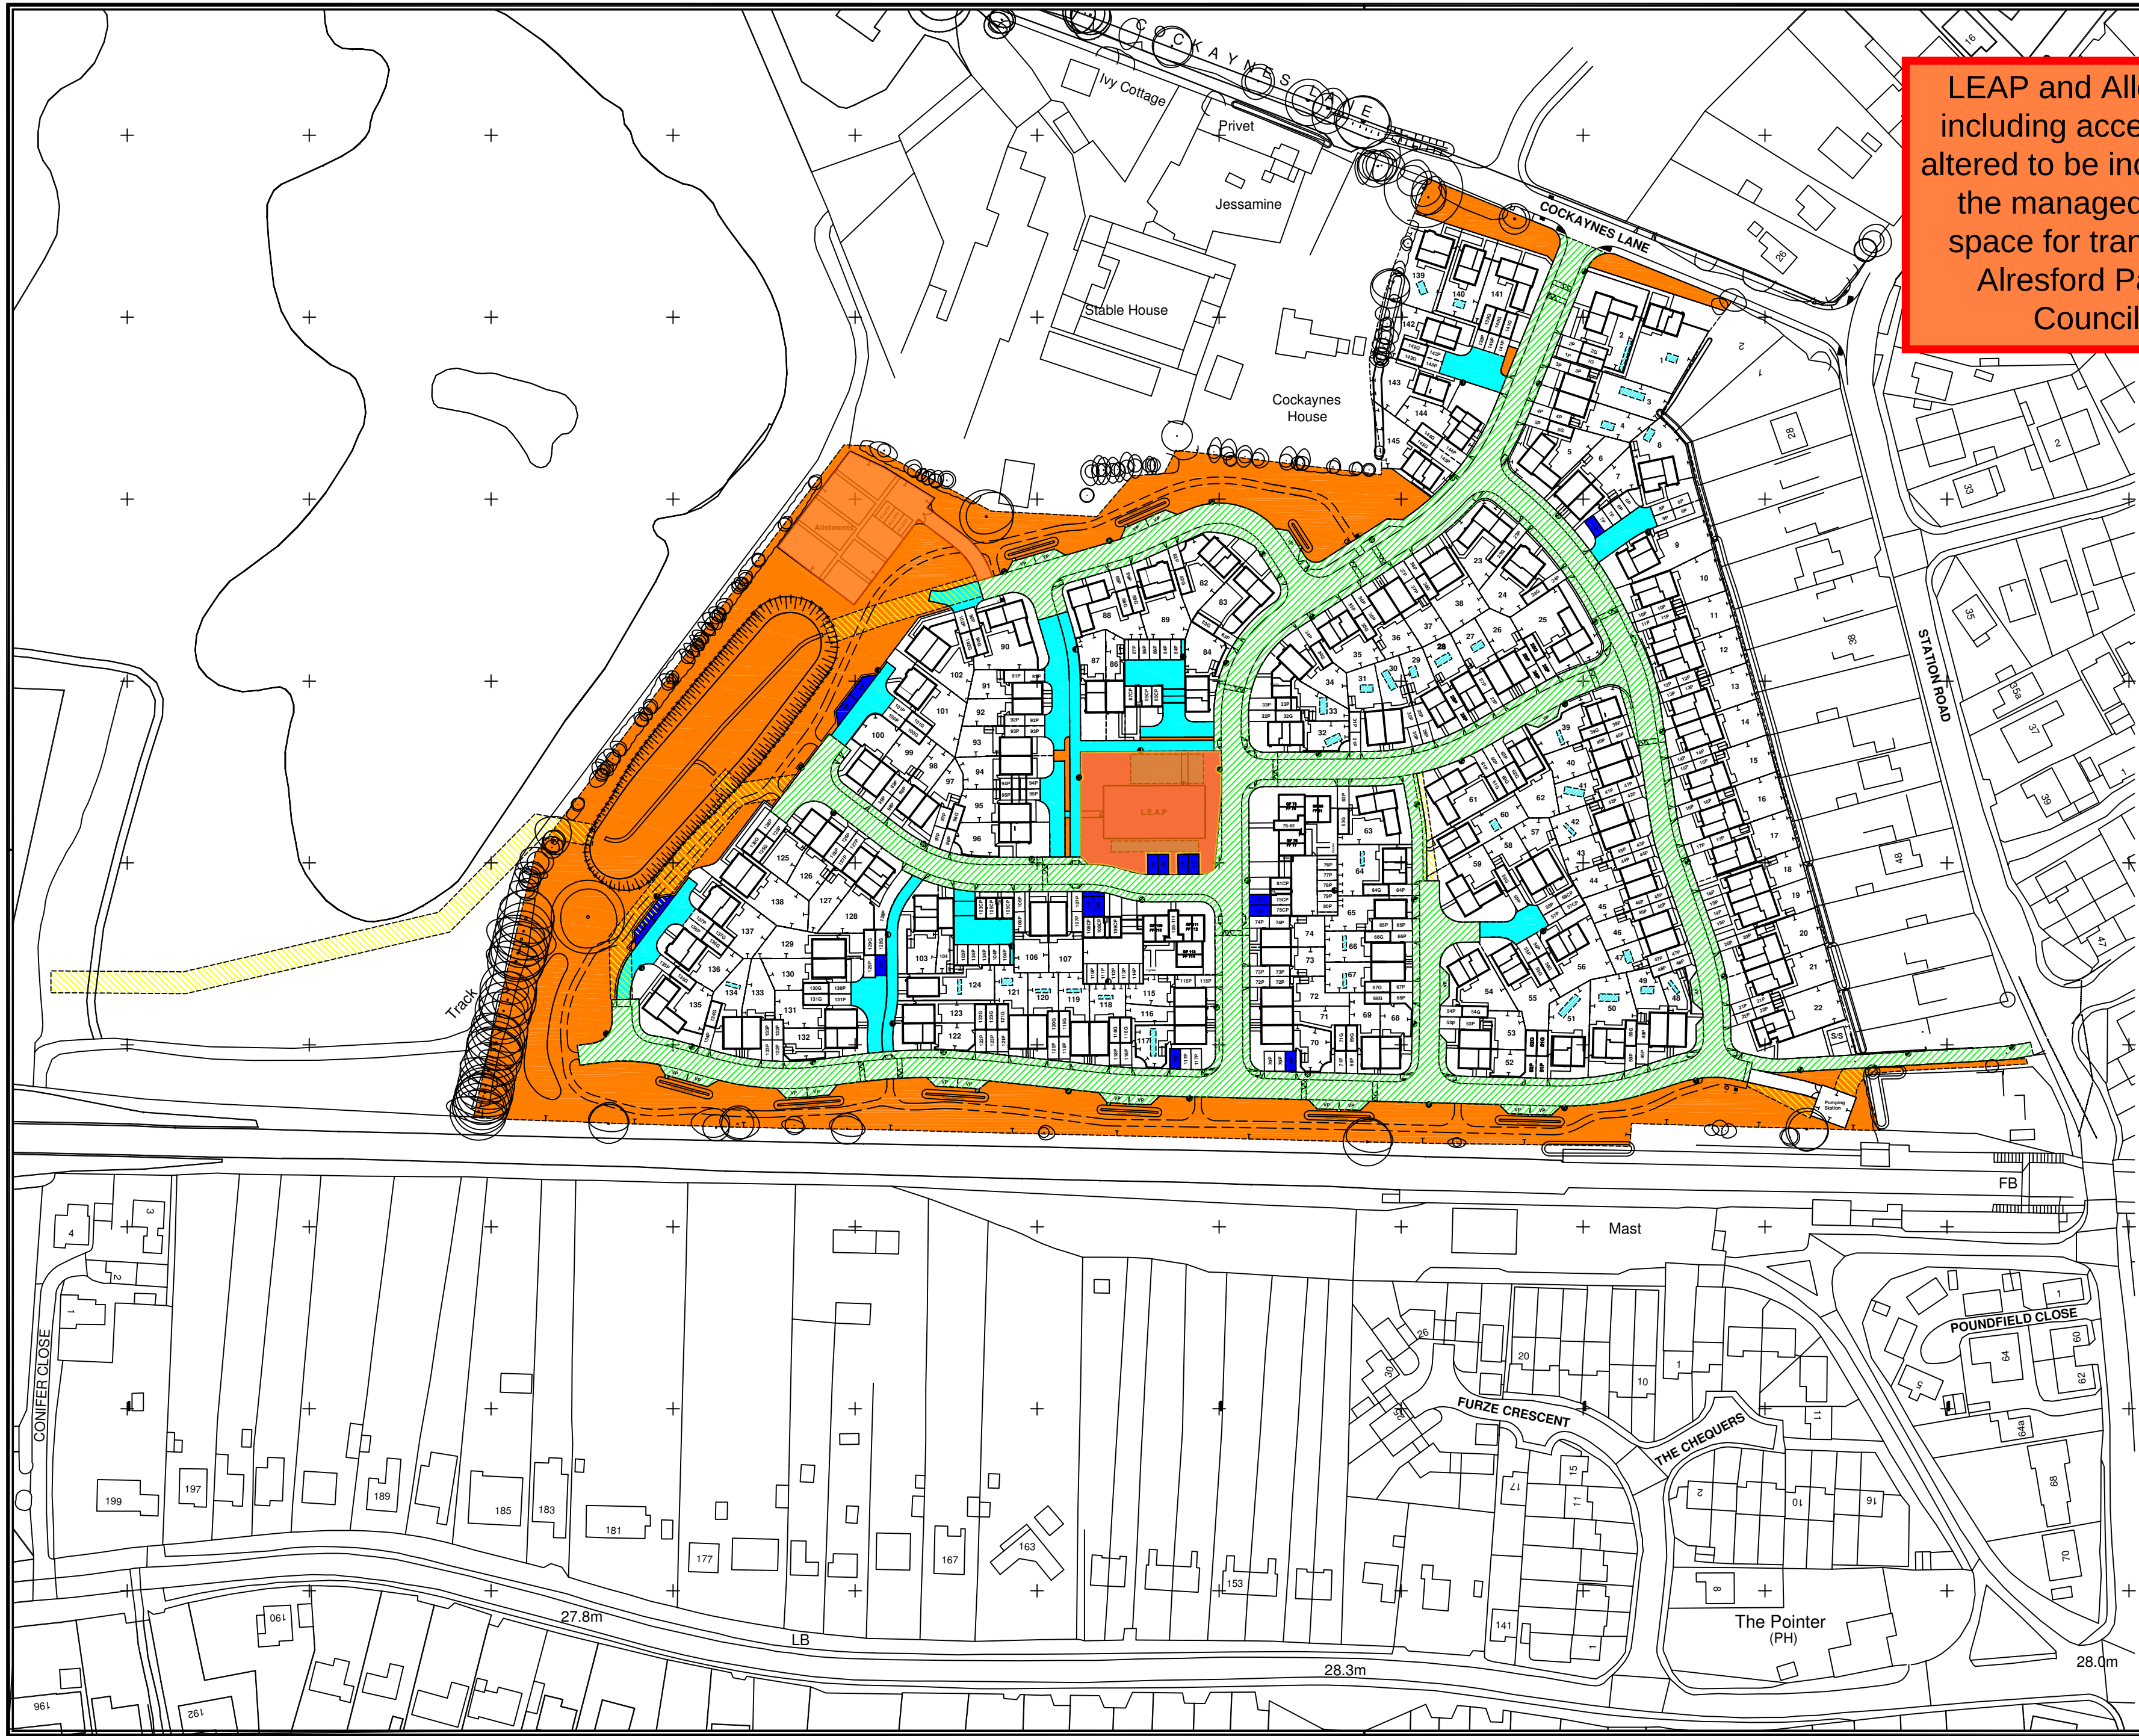

LEAP and Allotment including access way altered to be included in the managed open space for transfer to Alresford Parish Council.

KEY

- PROPERTY/LOT
- GROUND FLOOR LEASEHOLD GARAGE
- MANAGED OPEN SPACE
- MANAGED ACCESSWAYS
- ALLOTMENTS
- AREA FOR ADOPTION AS PUBLIC HIGHWAY
- PRIVATE ACCESSES
- MANAGED VISITORS PARKING SPACES
- PROTECTED STRIP
- HOUSING ASSOCIATION
- HOUSING ASSOCIATION MANAGED AREA
- AQUACELLS
- VISIBILITY SPLAY
- PLOT BOUNDARY RESPONSIBILITY
- STREET LIGHTING
- PRIVATE LIGHTING

Rev	Date	Init	Revision Details
A	10.10.17	SB	AFFORDABLE TRANSFER PLAN AND MANAGED AREAS PLAN ADDED.
B	14.10.17	SB	AFFORDABLE TRANSFER PLAN AND MANAGED AREAS PLAN REVISED.
C	16.11.17	SB	IN LINE WITH CLIENT FEEDBACK, ADOPTABLE HIGHWAY EXTENTS REVISED TO REMOVE 500MM SERVICE STRIPS AFFORDABLE PLOTS 44-49 REVISED TO SUIT. AFFORDABLE TRANSFER & MANAGED AREAS PLANS AMENDED TO 1/1250 SCALE @ A2.
D	06.01.18	SB	OPEN MARKET PLOTS AND STREET LIGHTING ADDED.
E	26.04.18	SB	ALL PLANS UPDATED IN LINE WITH UPDATED PLANNING AND SECTION 38 & 104 LAYOUTS. AQUACELLS ADDED & MANAGED OPEN SPACE EXTENTS REVISED IN LINE WITH LAND REGISTRY FEEDBACK.
F	27.04.18	SB	"T" MARKS ADDED TO ALLOTMENT FENCE AND SOUTHERN SITE BOUNDARY. PLOTS 9,56,135,143 & 144 REVISED TO EXCLUDE CUT OUT FOR LIGHTING COLUMN.
G	14.05.18	SB	PLOTS 84 & 104 AND MANAGED AREAS REVISED TO REFLECT AMENDED PRIVATE LIGHTING LAYOUT.
H	11.06.18	SB	PLOTS 144 & 145 GARAGE ANNOTATION CORRECTED.
Rev	Date	Init	Revision Details
J	22.06.18	SB	PLOTS 61,125,126, PRIVATE AND ADOPTED LIGHTING, MANAGED AREAS, L.E.A.P & ADOPTED HIGHWAY REVISED TO REFLECT UPDATED S38 EXTENTS (21602-CIV-1251-1252 Section 38 Agreement Plans.dwg).
K	25.06.18	SB	HIGHWAY BUILDOUTS REMOVED FROM PLOT 59 AND ADDED TO VP OPPOSITE PLOT 83. MANAGED AREA EXTENTS REVISED TO SUIT.
L	24.07.18	SB	PLOTS 57 & 58 GARAGE ANNOTATION REVISED TO SHOW CAR PORTS.
M	03.04.19	COB	INDIVIDUAL PLANS FOR HA PLOTS 6,7, 20,21,26,27,28,29,44,45,46,47,48,49,73, 74,75,76,77,78,79,80,81,106,107 ADDED 85,87,103,105,108,109 G REVISED TO CP. CLIENT'S INSTRUCTION
N	19.06.19	COB	See note on LEAP and allotment in red text box
PW	22.05.24		

Project
**COCKAYNES LANE
ALRESFORD**

Title
MANAGED AREAS PLAN

Client
TAYLOR WIMPEY UK LTD

Region
EAST LONDON

Scale 1:1250 @ A2	Date OCTOBER 2017	
Dwg.no 97053000	Sheet 1 of 1	Rev.no N

DDP&S LTD
Deed Plans & Title Plan Overlays
Rock Cottage,
Holywell Road, Malvern,
WR14 4LF
Tel: 01684 899497 E-mail: mail@deedplans.com